

NOTES:

1. INSTALLATION MUST COMPLY WITH NATIONAL, STATE AND LOCAL ELECTRICAL REGULATIONS.
2. PLEASE REFER TO PRODUCT DOCUMENTATION FOR FURTHER INFORMATION.
- △3. UTILITY SOURCE MUST BE 1PH 220/230/240VAC (1PH+N+G) 50/60Hz OR 3PH 380/400/415VAC (3PH+N+G) 50/60Hz PROVIDED BY OTHERS.
NEUTRAL AND GROUND CONTINUITY IS SHOWN ON SHEET 2 OF THIS DRAWING.
- △4. DASHED LINES BETWEEN UNITS (- - -) REPRESENT CABLING PROVIDED BY OTHERS.
- △5. THE SYMMETRA LX, SKU NUMBER SYA8K8I, IS SHOWN IN A NON-REDUNDANT CONFIGURATION, HAVING TWO (2) POWER MODULES (SYPM4KI) AND TWO (2) BATTERY MODULES (SYBT5), PROVIDING UP TO 8kVA POWER. A FURTHER POWER MODULE (SYPM4KI) CAN BE PURCHASED SEPARATELY AND INSTALLED IN THE SYSTEM, PROVIDING REDUNDANCY.
- △6. UP TO TWO (2), OPTIONAL, SYMMETRA LX PDU PANELS CAN BE PURCHASED SEPARATELY AND INSTALLED TO PROVIDE FURTHER LOAD CONNECTIONS.
7. BLOCKS SHOWN WITH DASHED (-----) LINES REPRESENTS AVAILABLE SPACE/SLOTS FOR ADDITIONAL POWER MODULES AND BATTERY UNITS.
8. UP TO SEVEN (7) ADDITIONAL EXTENSION BATTERY CABINETS CAN BE CONNECTED TO INCREASE THE RUNTIME FURTHER.
- △9. A SMALLER OUTPUT BREAKER MAY BE USED TO ALLOW CIRCUIT BREAKER COORDINATION, HOWEVER THIS MAY REDUCE THE MAXIMUM LOAD kVA SUPPORTED.


THIS DRAWING AND SPECIFICATIONS HEREIN ARE THE PROPERTY OF SCHNEIDER ELECTRIC AND SHALL NOT BE COPIED, REPRODUCED OR USED IN WHOLE OR IN PART, AS THE BASIS FOR THE MANUFACTURE OR SALE OF ITEMS WITHOUT WRITTEN PERMISSION FROM SCHNEIDER ELECTRIC. THIS DRAWING IS BASED UPON LATEST AVAILABLE INFORMATION AND IS SUBJECT TO CHANGE WITHOUT NOTICE.



TITLE: SYMMETRA LX 8kVA TOWER
 INPUT: 220/230/240VAC (1φ+N+G) 50/60Hz
 OR 380/400/415VAC (3φ+N+G) 50/60Hz
 OUTPUT: 220/230/240VAC 50/60Hz
 SYSTEM SINGLE-LINE DIAGRAM
 PROJECT: SUBMITTAL DRAWINGS SHEET 1 OF 2

DWG NO: SYA8K8I-SD
 DRAWN: S CUNHA 13-JAN-11
 ENGINEER: K WHITE 13-JAN-11
 APPROVED: N WHITING 13-JAN-11

REV. 2
 PROJ. ANGLE
 N/A

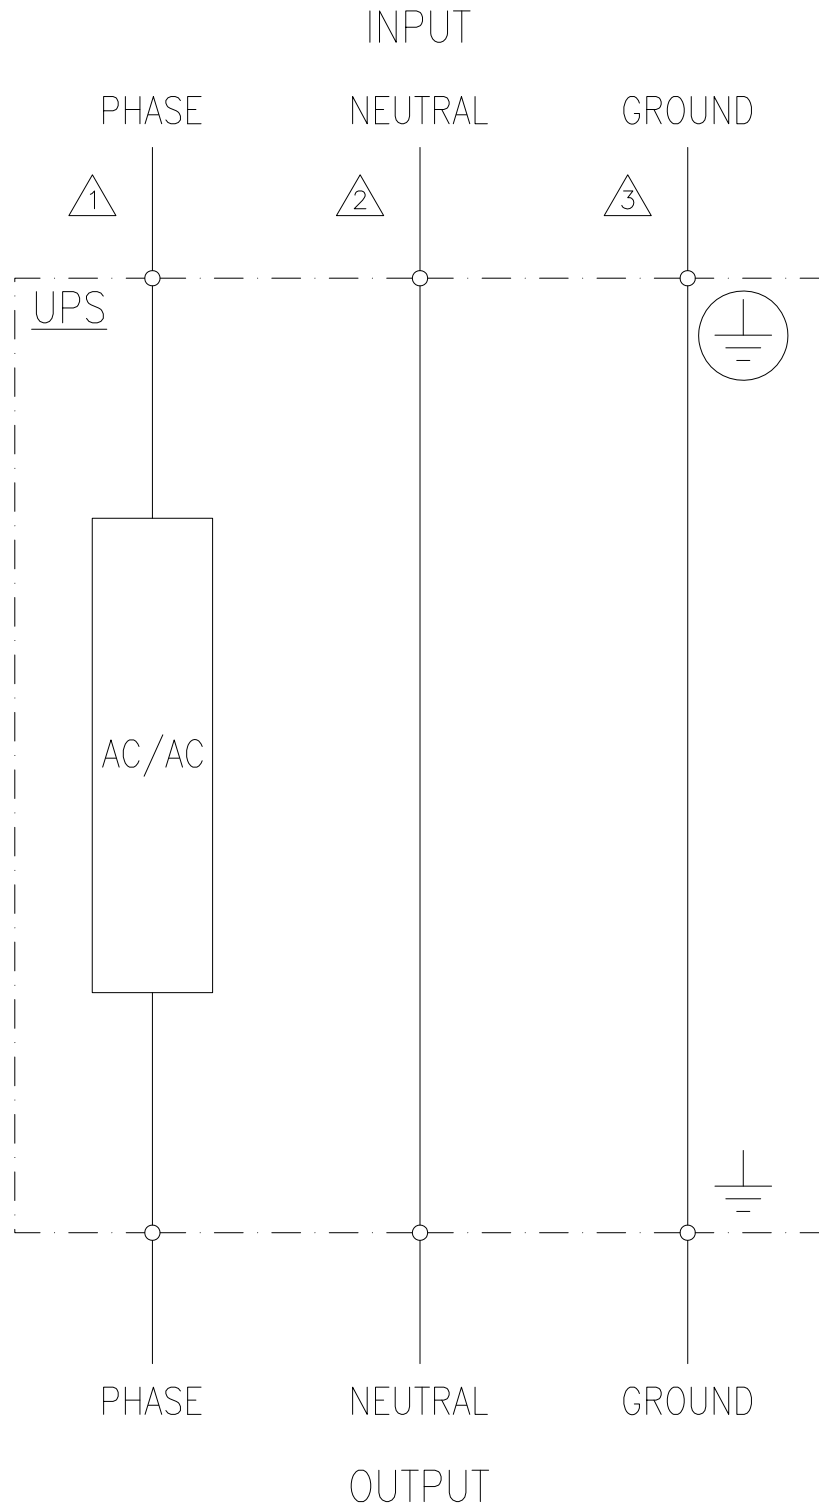

NOTES:

- △1. ONE OR MORE PHASE CONNECTIONS DEPENDING ON MODEL.
- △2. INPUT AND OUTPUT NEUTRAL ARE PERMANENTLY CONNECTED.
- △3. INPUT AND OUTPUT GROUND ARE PERMANENTLY CONNECTED.
- 4. EQUIPMENT IS NOT CONSIDERED A SEPARATELY DERIVED SYSTEM.
(REF NEC 2008 ARTICLE 250.20.(D))

THIS DRAWING AND SPECIFICATIONS HEREIN ARE THE PROPERTY OF SCHNEIDER ELECTRIC AND SHALL NOT BE COPIED, REPRODUCED OR USED IN WHOLE OR IN PART, AS THE BASIS FOR THE MANUFACTURE OR SALE OF ITEMS WITHOUT WRITTEN PERMISSION FROM SCHNEIDER ELECTRIC. THIS DRAWING IS BASED UPON LATEST AVAILABLE INFORMATION AND IS SUBJECT TO CHANGE WITHOUT NOTICE.



TITLE: SYMMETRA LX 8kVA TOWER
 220/230/240VAC (1 ϕ +N+G) 50/60Hz, OR
 INPUT: 380/400/415VAC (3 ϕ +N+G) 50/60Hz
 OUTPUT: 220/230/240VAC 50/60Hz
 NEUTRAL AND GROUND CONTINUITY

DWG NO: SYA8K81-SD

REV. 0

DRAWN: S CUNHA 13-JAN-11

PROJ. ANGLE

ENGINEER: K WHITE 13-JAN-11

APPROVED: N WHITING 13-JAN-11

PROJECT: SUBMITTAL DRAWINGS SHEET 2 OF 2

N/A